


Plan View
Scale 1" = 2'

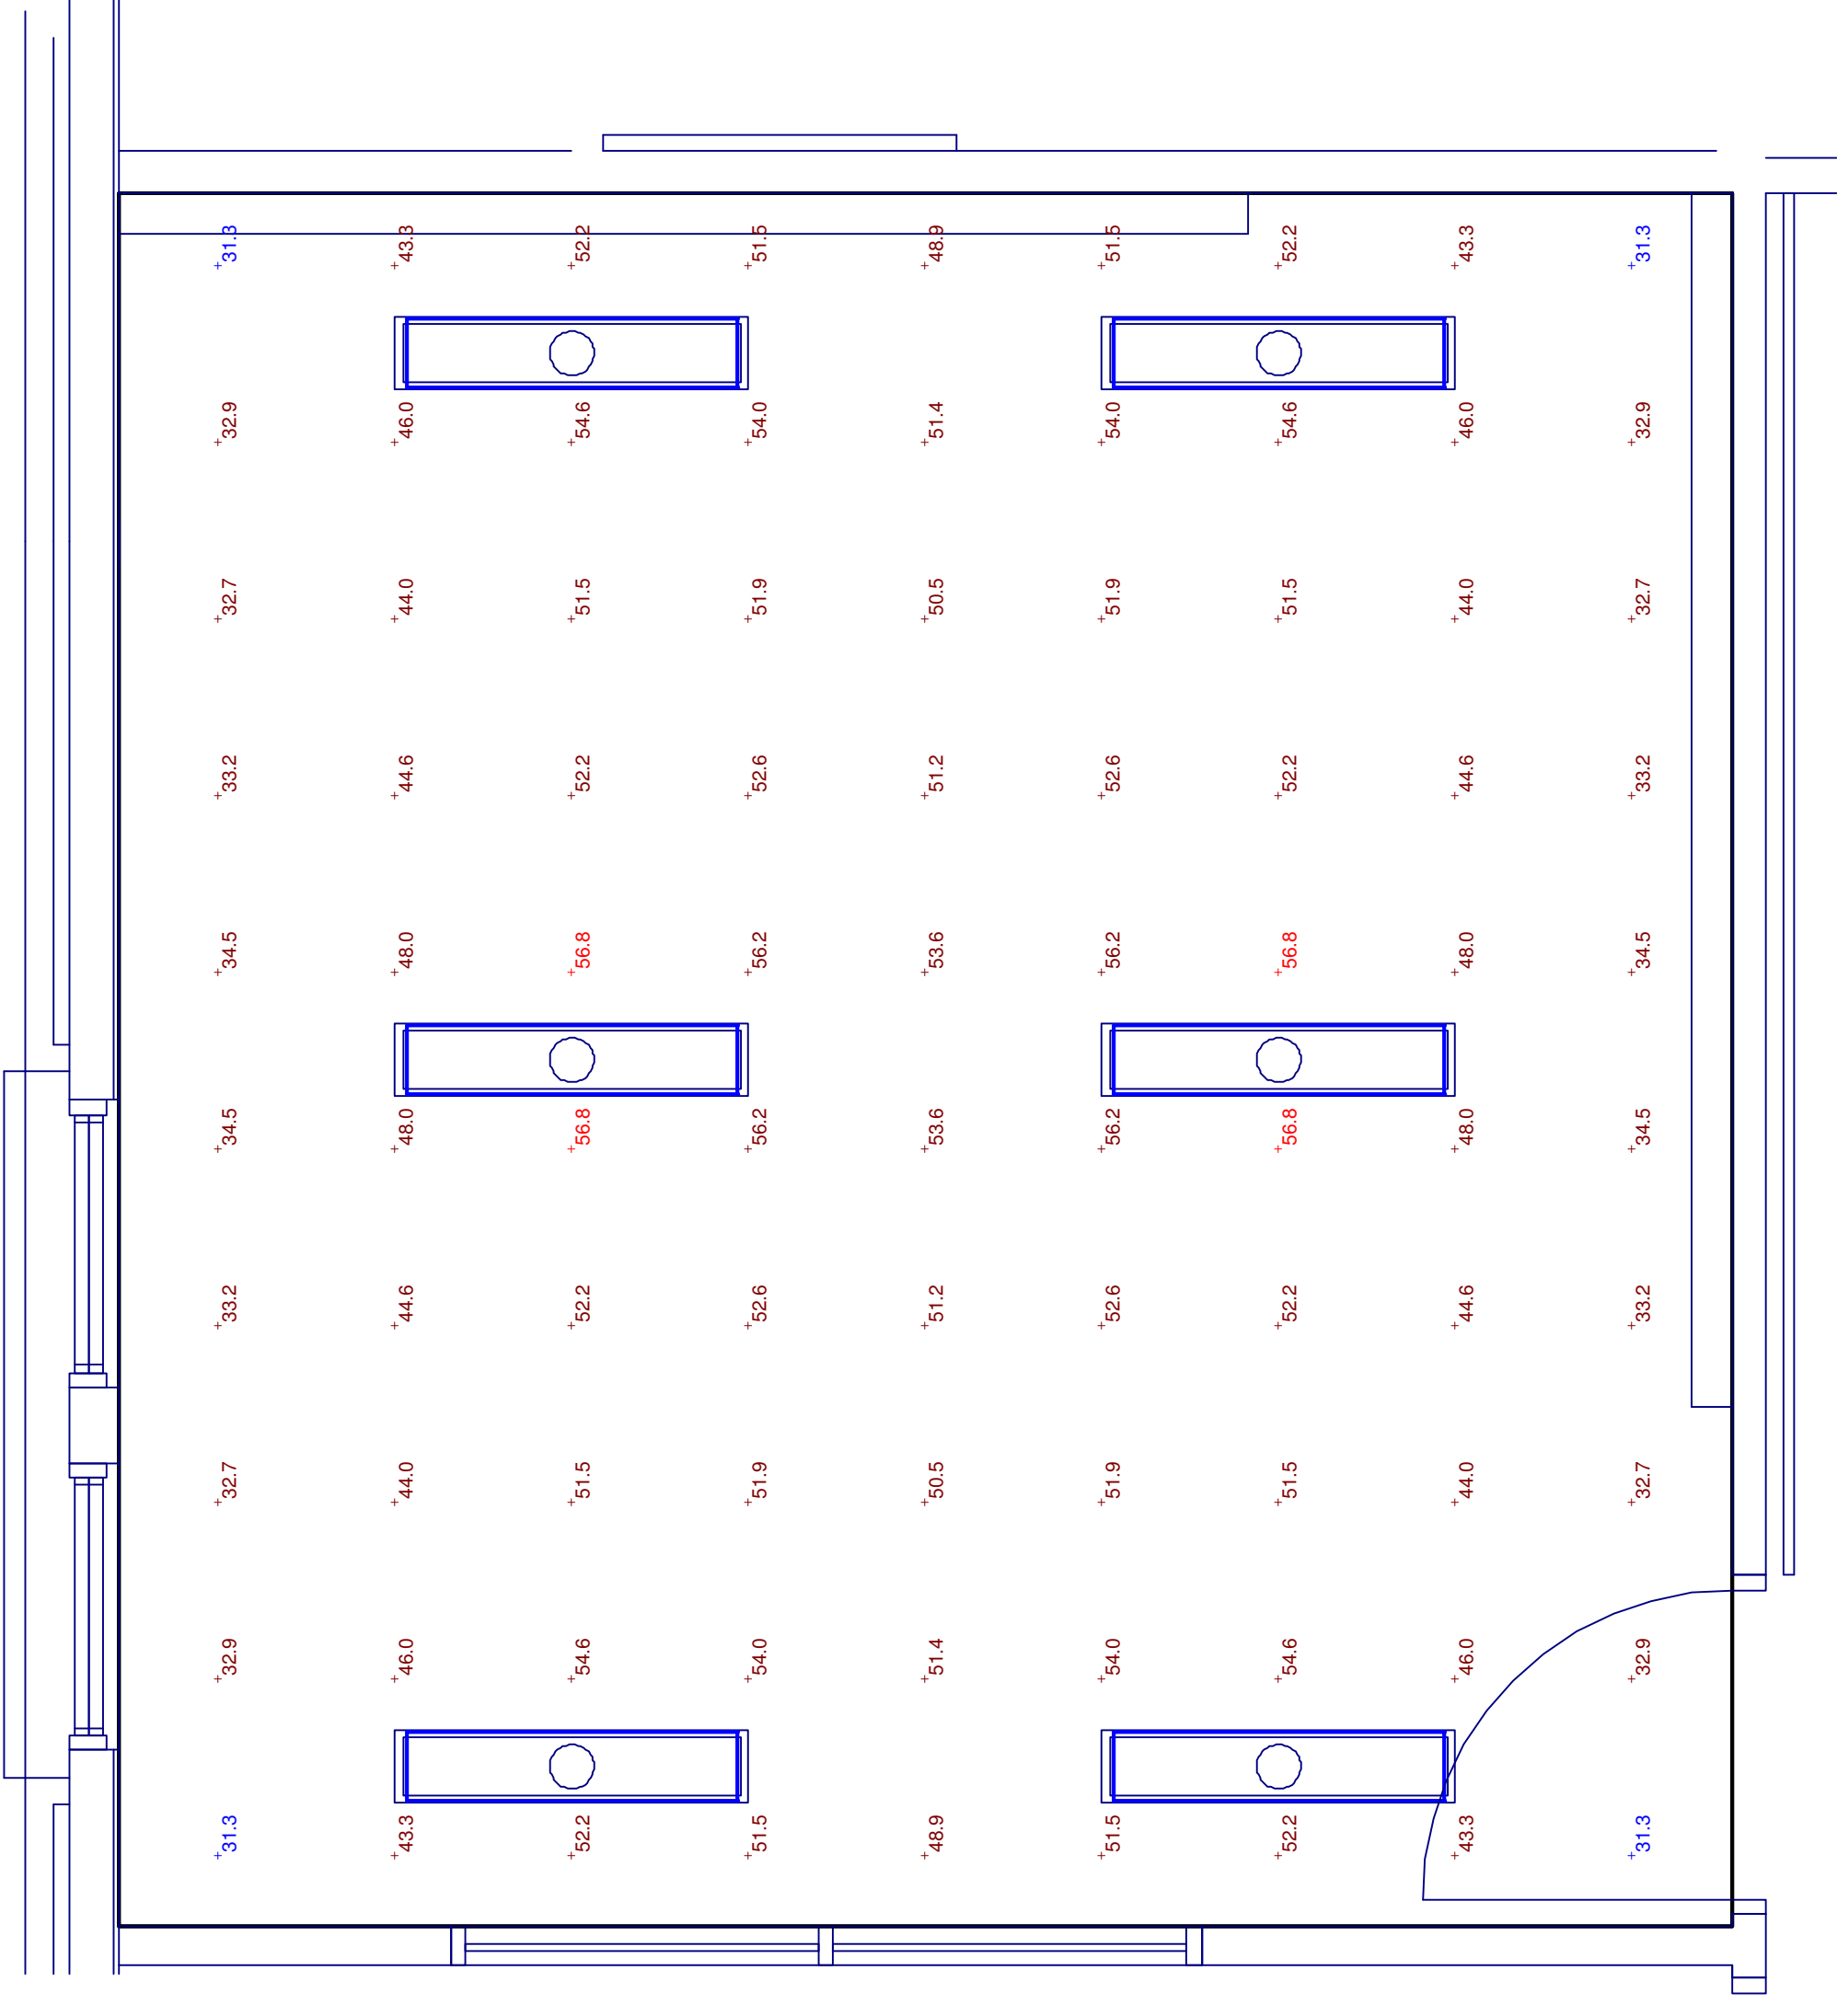

LAUNDRY

104

CALCULATIONS TAKEN AT 36" AFF
DIMMING LED SURFACE-MOUNTED FIXTURES

LUMINAIRE SCHEDULE			
Symbol	Catalog Number	Description	Watts
□	STL440L D40 LP840	SURFACE VOLUMETRIC LED W/60° BEAM ANGLE LONG. WITH 4000 KRAVE LIGHTS, 4000K DRIVER, 4000K LEDs, AND LINEAR FACETED REFRACTOR	40.7